

The Phoenix  
Apartments  
Interior Alterations

5802 Annapolis Road  
Bladensburg, Maryland 20710


NOVITSKE ARCHITECTS

201 North Fairfax Street, Suite 33  
Alexandria VA 22314  
703 535 7899, 703 535 8840 fax




**OCI ASSOCIATES, INC.**  
CONSULTING ENGINEERS  
Orlando • Ft. Pierce • West Palm Beach • Ft. Myers • Tampa  
Washington, D.C.  
7700 Leeburg Pkwy, Suite 201  
Ft. Myers, FL 33905  
Phone: (772) 488-2200 Fax: (772) 488-2205  
www.ociassociates.com  
CERTIFICATE OF AUTHORIZATION #0201

I certify that these documents were prepared by or approved by me and that I am a duly licensed professional engineer under the laws of the State of Maryland, license number 18505 expiration date 6/30/15.

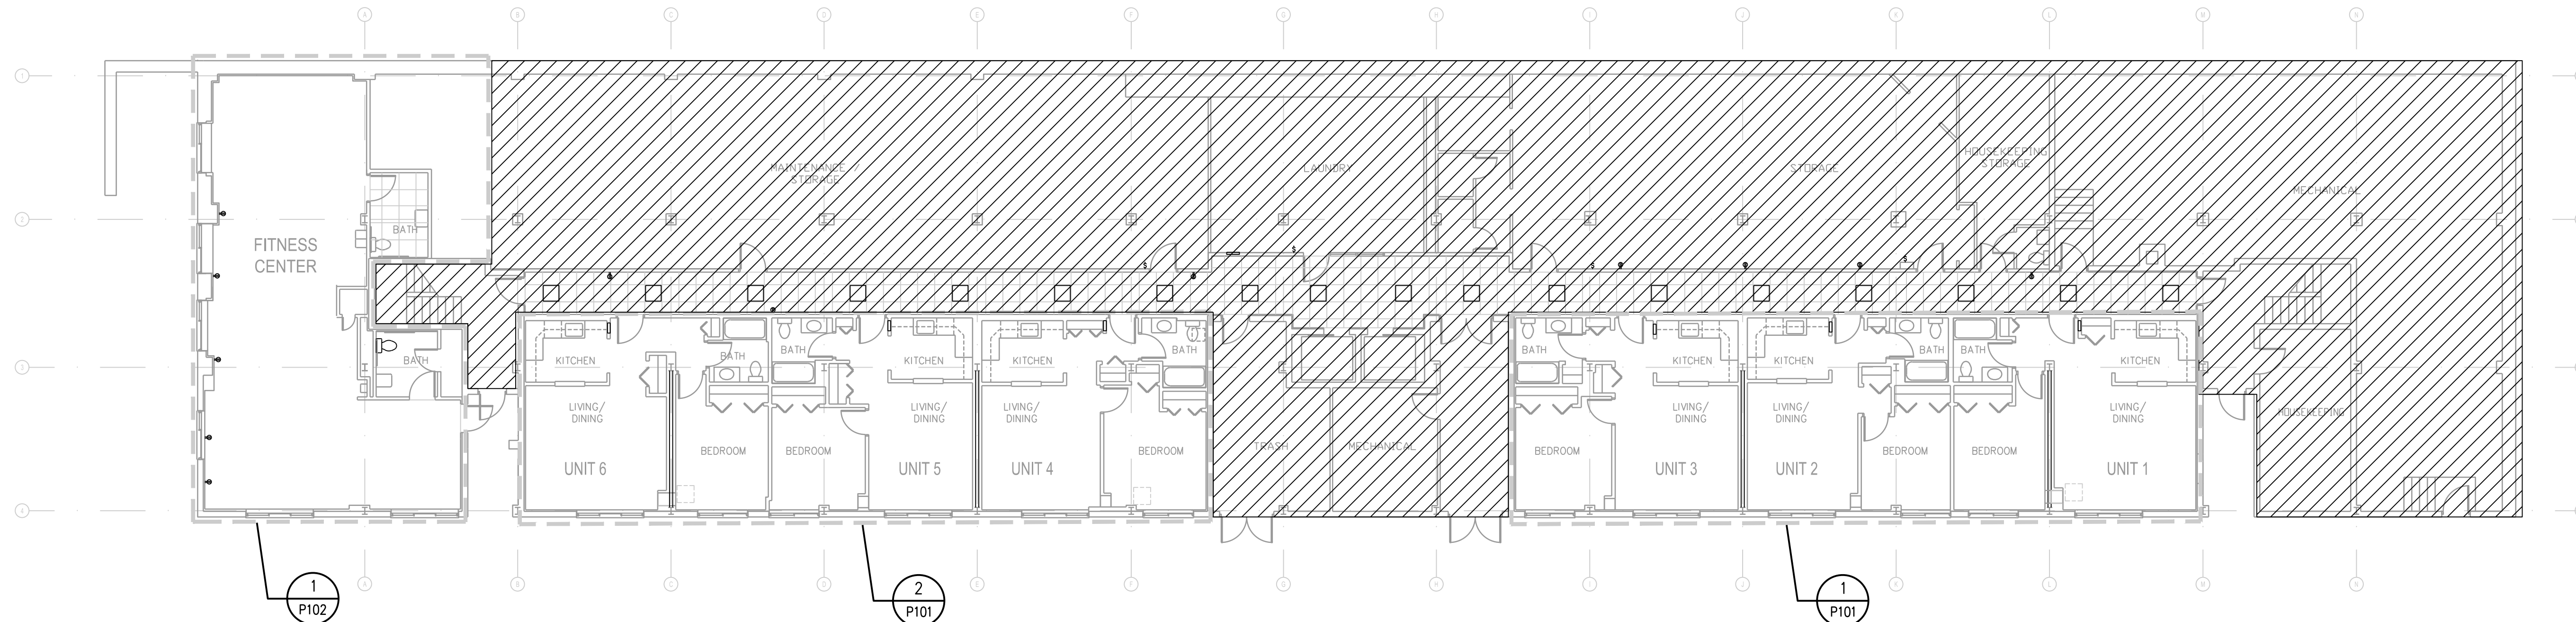

key plan

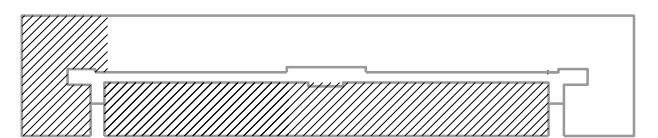

graphic scales

project: 21413  
phase: PERMIT SET  
date: 16 February 2015  
revisions:

BASEMENT FLOOR PLAN  
BLDG 5800 - PLUMBING

**P-100**

1  
P-100  
BASEMENT FLOOR PLAN BLDG 5800 - PLUMBING  
SCALE: 3/32"=1'-0"

