

The Phoenix
Apartments
Interior Alterations

5802 Annapolis Road
Bladensburg, Maryland 20710


NOVITSKE ARCHITECTS

201 North Fairfax Street, Suite 33
Alexandria VA 22314
703 535 7899, 703 535 8840 fax




OCI ASSOCIATES, INC.
CONSULTING ENGINEERS
Orlando • Ft. Pierce • West Palm Beach • Ft. Myers • Tampa
Washington, D.C.
7700 Leeburg Pike, Suite 201
Ft. Oglethorpe, GA 30753
Phone: (770) 488-0200 Fax: (770) 488-0205
www.ociassociates.com
CERTIFICATE OF AUTHORIZATION #6281

I certify that these documents were prepared by or approved by me and that I am a duly licensed professional engineer under the laws of the State of Maryland, license number 18505 expiration date 6/30/15.

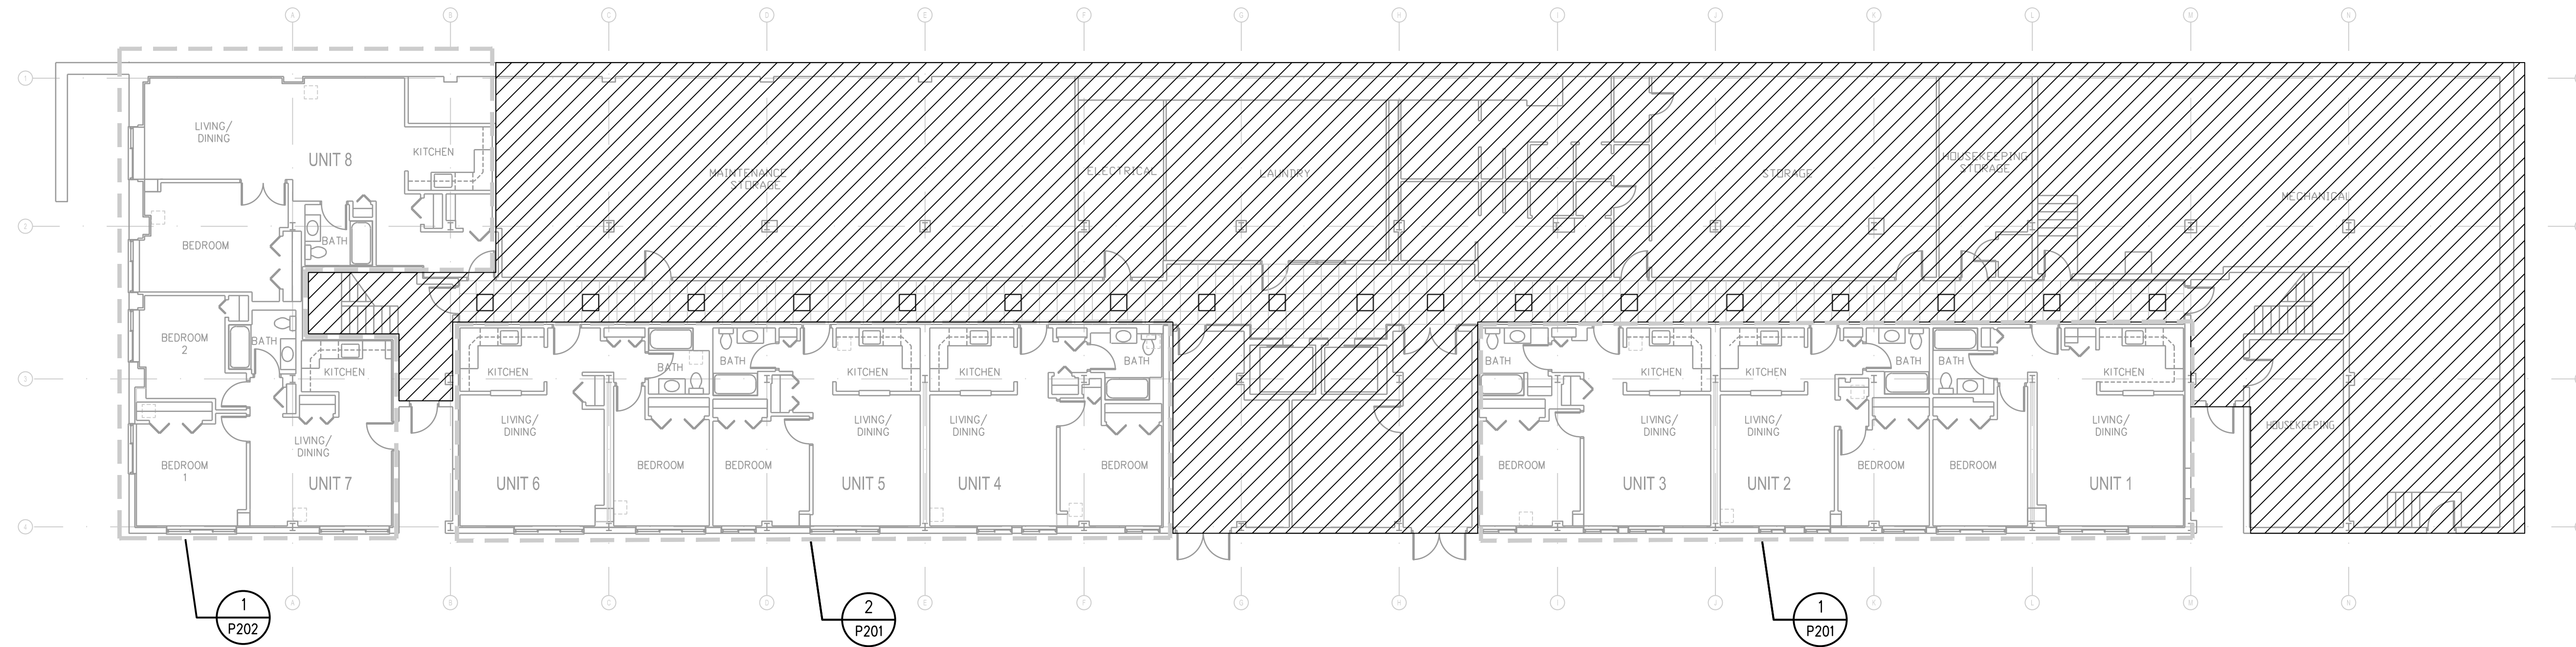

key plan

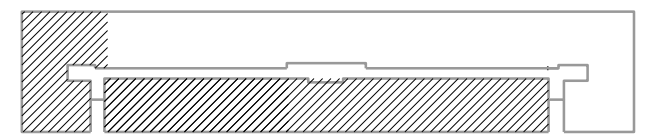

graphic scales

project: 21413
phase: PERMIT SET
date: 16 February 2015
revisions:

BASEMENT FLOOR PLAN
BLDG 5802 - PLUMBING

P-200

1
P-200
BASEMENT FLOOR PLAN BLDG 5802 - PLUMBING
SCALE: 3/32"=1'-0"
NORTH
plan